

A

B

C

D

E



A

B



C

D


E

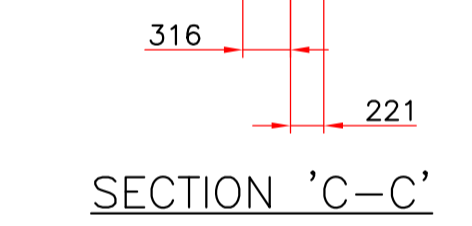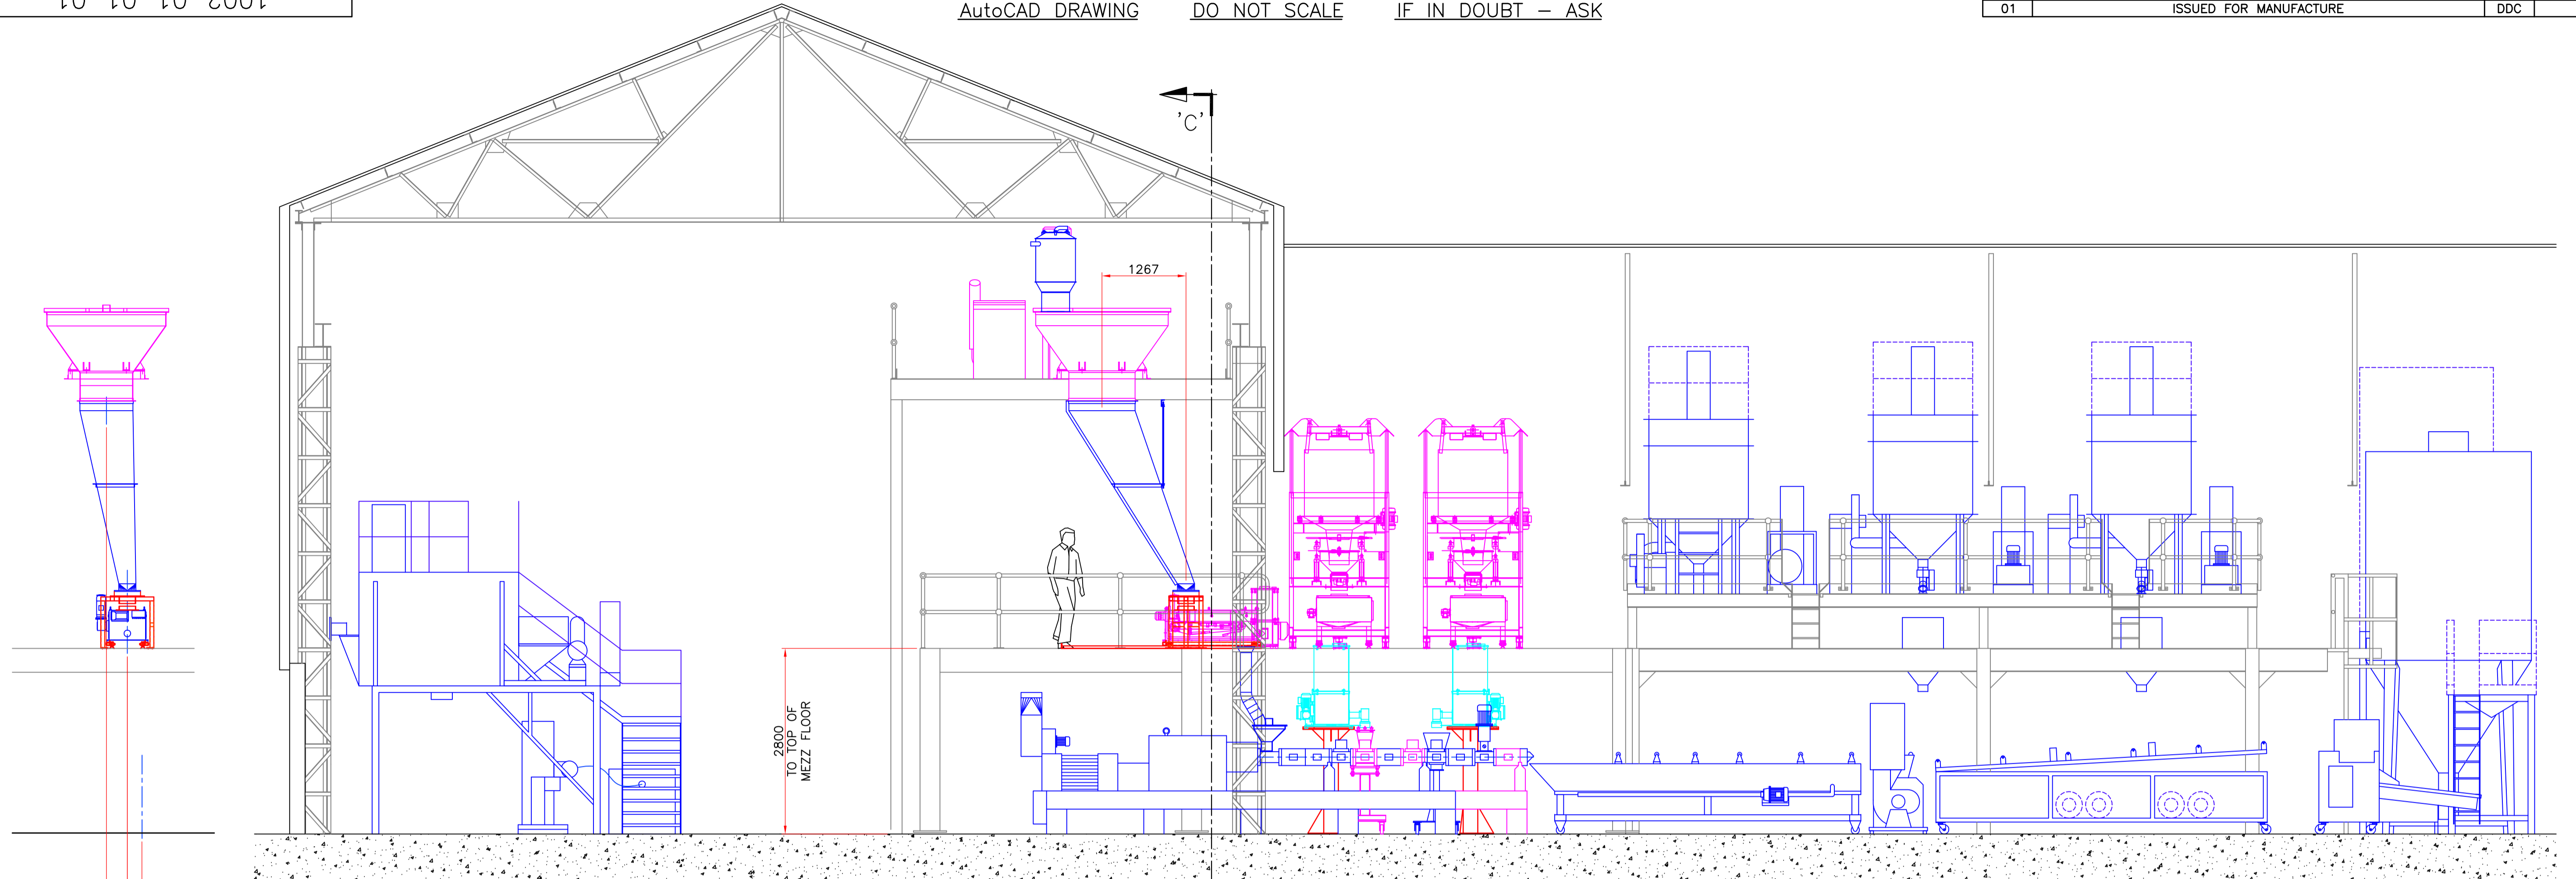

SECTION 'A-A'  
SECTION THRO' TSK-90  
4234

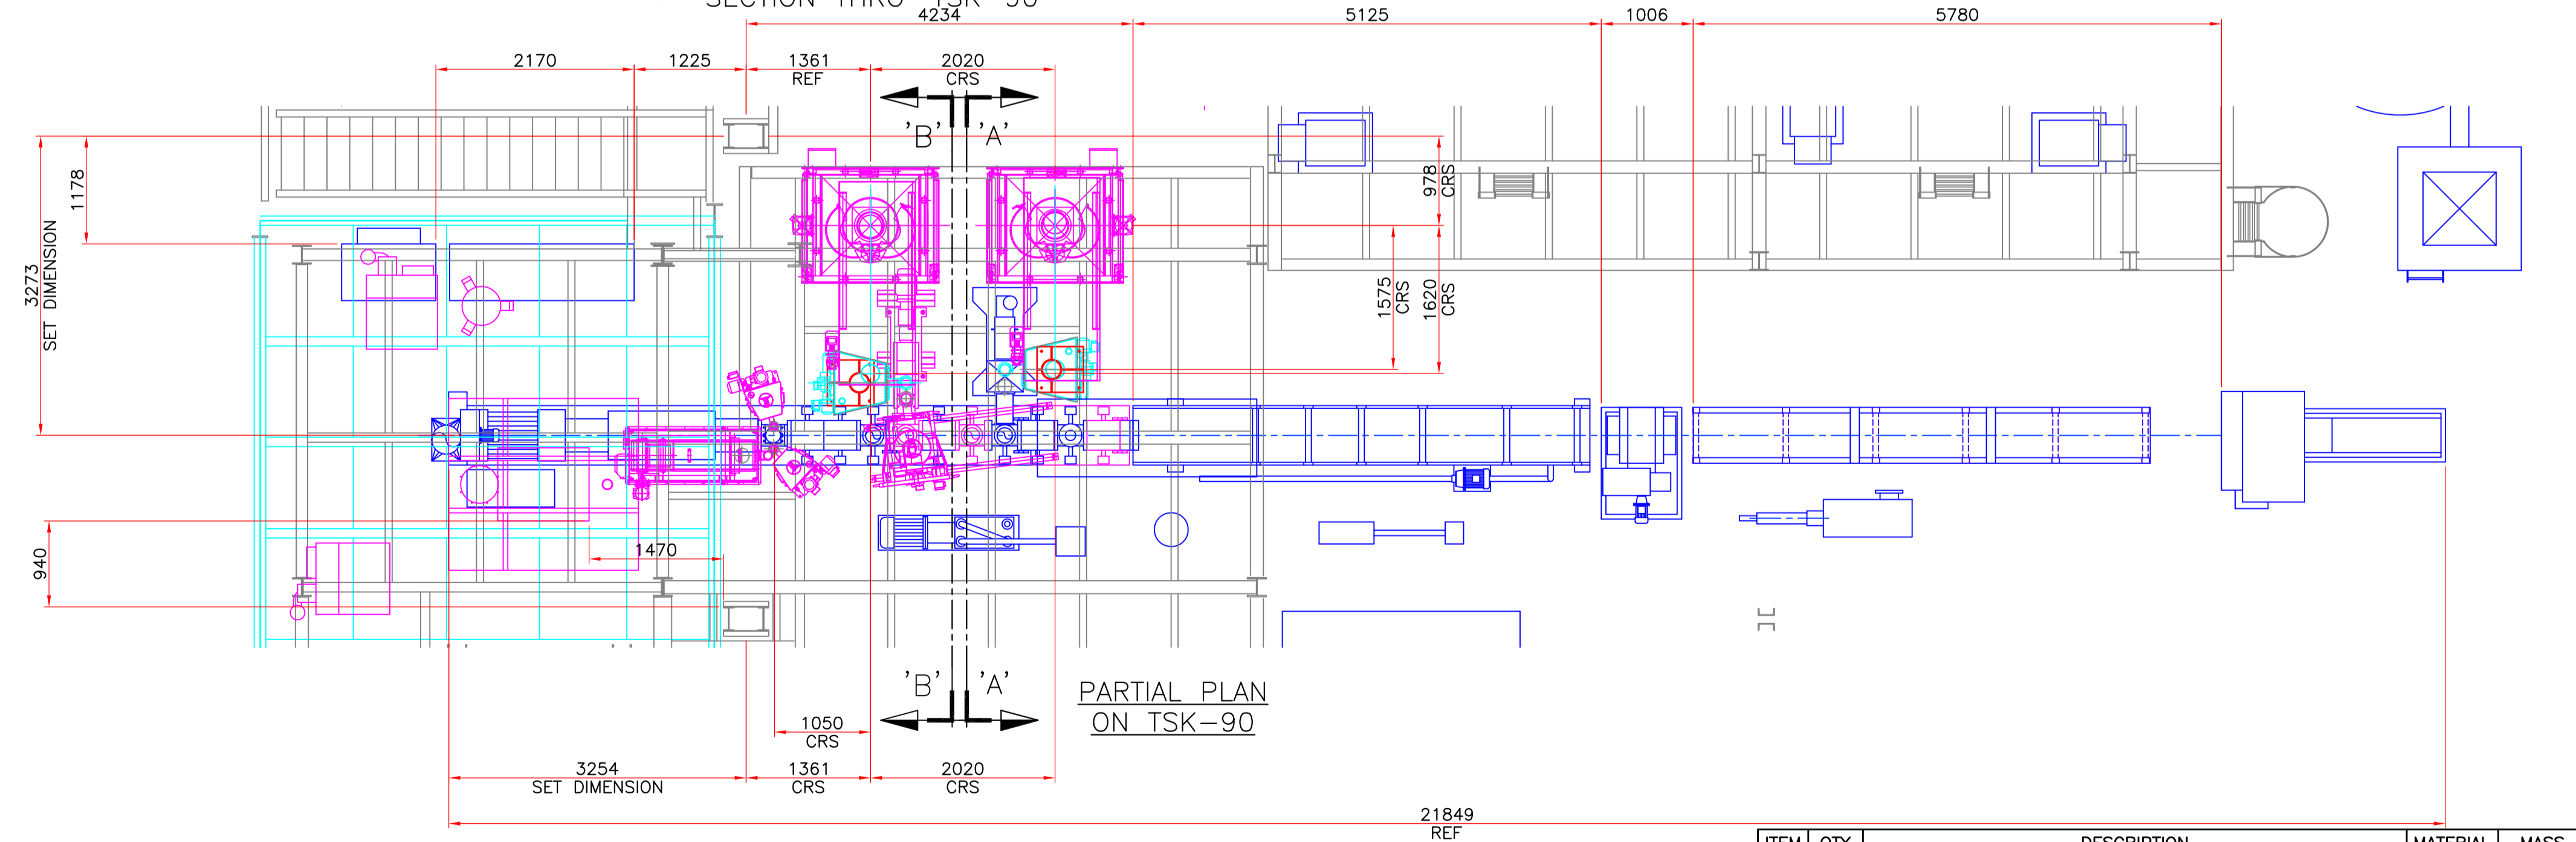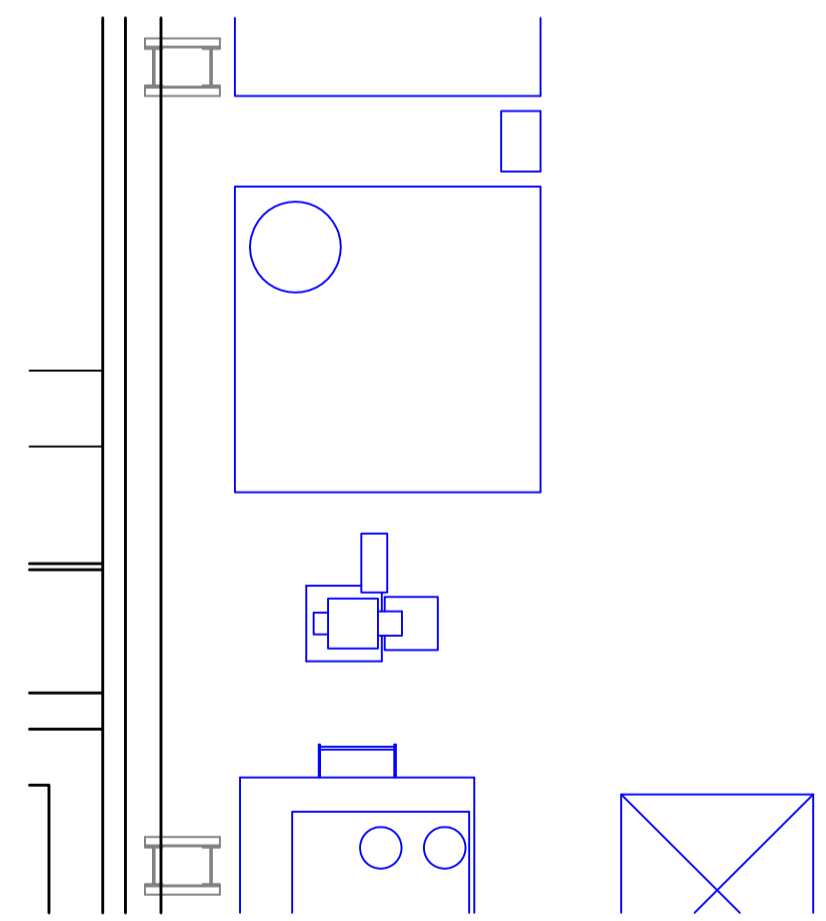

PARTIAL PLAN  
ON TSK-90

ITEM	QTY	DESCRIPTION	MATERIAL	MASS
 <b>Engineering Solutions Limited</b> Technology Centre, Wolverhampton Science Park, Wolverhampton, WV10 9RU Tel:- 0845 226 8531 Fax:- 0845 226 8532 email: info@ddc-uk.com				
<small>DDC Engineering Solutions Limited, WOLVERHAMPTON ENGLAND, considers this drawing and the subject matter hereof to be proprietary and confidential and such shall not be reproduced, copied or used except to the extent authorized by DDC in writing. All copyright, patent and design rights are reserved.</small>				
Scale:		1:50		
Title:		SECTION AND PART PLAN SHOWING PROPOSED LOCATION OF TSK-90 LINE AT TAT BANK ROAD, OLDBURY		
Job No.		Drg No. 1002_01_01_01		

